

BREAKER INTERRUPTING CAPACITY: 22,000		PANEL SCHEDULE GH										BRACED FOR MINIMUM 22,000 AMPS SYMMETRICAL	
120/208V, 3Ø, 4W 400 AMP M.L.O.		FLUSH MOUNTED											
CKT	EQUIPMENT SERVED	BREAKER TRIP POLE	KVA/PHASE			KVA/PHASE			BREAKER POLE TRIP	EQUIPMENT SERVED			CKT
1	WALK-IN COOLER CONDENSER	20 2	1.2	1.2		.7	.3		1 20	FLOOR WARMER			2
3	WAREWASHER	20 1		1.6					1 20	REFRIGERATED COUNTER TOP			4
5	REACH-IN FREEZER	20 1	1.1			2.3	.2		2 30	REFRIGERATOR UNDERCOUNTER			6
9	FLOOR MIXER	20 3		1.4	1.4		2.3	1.1	1 20	ESPRESSO/CAPPUICINO MACHINE			8
11	WALK-IN COOLER EVAPORATOR	20 1		.1		.18	1.2		2 20	REFRIGERATOR SANDWICH PREP			10
13	CONVENIENCE RECEPT.			.36			1.2	1.2	2 20	CONVENIENCE RECEPTACLE			12
15	BREAD SLICER			.7			1.2		2 20	OVEN/MICROWAVE			14
17	OVEN ROTATING RACK	20 2		.9	.9		.5	1 20	OVEN/MICROWAVE				16
19	OVEN PICARD	20 2		1.1		.36	1.2			FOOD SLICER			18
21	DOUGH ROLLER	20 1	1.0		1.1		1.2			CONVENIENCE RECEPTACLE			20
23	UNDERCOUNTER ICE MAKER			.7		.36	1.1			TEA BREWER			22
25	FLOOR MIXER			1.1			.9			REFRIGERATED GLASS DISPLAY			24
27	EXHAUST FAN HEF1			.9		.54				RECEPT. POS STATIONS			26
29	EXHAUST FAN HEF2			1.1		.54				REFRIGERATOR AIR CURTAIN TYPE 1			28
31	SPARE					4.0		2 60		CONVENIENCE RECEPTACLES			30
33	AHU#1	80 2	5.4		5.4	4.0	1.9		2 40	CONVENIENCE RECEPTACLES			32
35	AHU#2	80 2		5.4	5.4		1.9		1 20	CONVENIENCE RECEPTACLES			34
37	HPU#1	50 2		2.8	2.8					CONVENIENCE RECEPTACLES			36
39	HPU#2	50 2		2.8	2.8					CONVENIENCE RECEPTACLES			38
41	LIGHTING	20 1		.1	.9					CONVENIENCE RECEPTACLES			40
43	GAS WATER HEATER			.18	.1					CONVENIENCE RECEPTACLES			42
45	SERVICE RECEPT.									CONVENIENCE RECEPTACLES			44
47	POS SYSTEM									CONVENIENCE RECEPTACLES			46
49	OAU#1	125 3	8.6	8.6	8.6					CONVENIENCE RECEPTACLES			48
51										CONVENIENCE RECEPTACLES			50
53										CONVENIENCE RECEPTACLES			52
55										CONVENIENCE RECEPTACLES			54
57										CONVENIENCE RECEPTACLES			56
59										CONVENIENCE RECEPTACLES			58
61										CONVENIENCE RECEPTACLES			60
63										CONVENIENCE RECEPTACLES			62
65										CONVENIENCE RECEPTACLES			64
67										CONVENIENCE RECEPTACLES			66
69										CONVENIENCE RECEPTACLES			68
71										CONVENIENCE RECEPTACLES			70
73										CONVENIENCE RECEPTACLES			72
SINGLE SECTION PANEL		TOTAL CONNECTED KVA 39.70 35.82 35.00 ① GFI CIRCUIT BREAKER											
		A B C											

BREAKER INTERRUPTING CAPACITY: 22,000		PANEL SCHEDULE Y										BRACED FOR MINIMUM 22,000 AMPS SYMMETRICAL	
120/208V, 3Ø, 4W 100 AMP M.L.O.		FLUSH MOUNTED											
CKT	EQUIPMENT SERVED	BREAKER TRIP POLE	KVA/PHASE			KVA/PHASE			BREAKER POLE TRIP	EQUIPMENT SERVED			CKT
1	LIGHTING	20 1	.7			4.0	4.0		2 50	AHU-8			2
3	RECEPT. YOGA			.36					2 30	HPU-8			4
5	SPARE					1.5	1.5		1 20	SPACE			6
7													8
9													10
11													12
13													14
15	SPACE												16
17													18
19													20
		TOTAL CONNECTED KVA 6.20 4.36 2.04											
		A B C											

BREAKER INTERRUPTING CAPACITY: 22,000		PANEL SCHEDULE HPA										BRACED FOR MINIMUM 22,000 AMPS SYMMETRICAL	
120/208V, 3Ø, 4W 100 AMP M.L.O.		SURFACE MOUNTED											
CKT	EQUIPMENT SERVED	BREAKER TRIP POLE	KVA/PHASE			KVA/PHASE			BREAKER POLE TRIP	EQUIPMENT SERVED			CKT
1	LIGHTING ①	20 1	.6			4.0	4.0		2 50	AHU#6			2
3	RECEPT.			.72					2 25	HPU#6			4
5	SERVICE RECEPT.			.18		1.4	1.4		1 20	SPACE			6
7	COMM BACKBOARD												8
9	SPACE												10
11													12
13													14
15													16
17													18
19													20
21													22
23													24
		TOTAL CONNECTED KVA 6.18 4.72 1.58 ① ROUTE THRU CONTACTOR. SEE LIGHTING CONTROL SCHEMATIC.											
		A B C											

BREAKER INTERRUPTING CAPACITY: 22,000		PANEL SCHEDULE FH										BRACED FOR MINIMUM 22,000 AMPS SYMMETRICAL	
120/208V, 3Ø, 4W 250 AMP M.L.O.		FLUSH MOUNTED											
CKT	EQUIPMENT SERVED	BREAKER TRIP POLE	KVA/PHASE			KVA/PHASE			BREAKER POLE TRIP	EQUIPMENT SERVED			CKT
1	RECEPT. KITCHEN	20 1	.36			1.0	.6		1 20	CONVECTION OVEN			2
3	COOLER EVAPORATOR			1.2	1.0		.6			REFRIGERATOR SANDWICH PREP			4
5	CONVECTION OVEN					.6	.6			REACH-IN REFRIGERATOR			6
7	SHUNT TRIP SPACE					.6	.6			REFRIGERATED DISPLAY CASE			8
9	SHUNT TRIP SPACE					.6	.6			REFRIGERATED DISPLAY CASE			10
11	REACH-IN FREEZER			.9		.6	.6			REFRIGERATED DISPLAY CASE			12
13	REACH-IN FREEZER			.9		1.5				WAREWASHER UNDERCOUNTER			14
15	CONVENIENCE RECEPTACLE			.18	.5	.1	.36			CONVENIENCE RECEPTACLE (POS)			16
17	FROSTER/CHILLER GLASS/MUG									RECEPT. DINING			18
19	BEER DISPENSER			1.0		.72				RECEPT. DINING			20
21	REFRIGERATOR UNDERCOUNTER			.5		.36				CONVENIENCE RECEPTACLE			22
23	REFRIGERATED DISPLAY CASE			.5		.3				HOOD CONTROL PANEL			24
25	ICE MAKER	30 2	1.5		1.5	.8	.8		3 15	HOOD EXHAUST FAN			26
27	SKILLET	60 2		4.5	4.5		.8		1 40	HOOD SUPPLY FAN			28
29	WALK-IN COOLER CONDENSER	20 2		2.0	2.0	.5	.5		3 15				30
31						.5							32
33						1.6	1.6		2 40	HPU#4			34
35							2.7	2.7	2 50	HPU#5			36
37	AHU#4	50 2	4.0		4.0	1.4	1.4		2 25	HPU#7			38
39	AHU#5	80 2		5.4	5.4		.9		1 20	FF#2			40
41	AHU#7	30 2		4.3	4.3		.1			GAS WATER HEATERS			42
43	LIGHTING	20 1		.9	.9					SERVICE RECEPTACLE			44
45										SPARE			46
47													48
49													50
51													52
53													54
55													56
57													58
59													60
61													62
63													64
65													66
67													68
69													70
71													72
SINGLE SECTION PANEL		TOTAL CONNECTED KVA 28.88 20.64 27.44 ① GFI CIRCUIT BREAKER ② PROVIDE WITH 120V SHUNT TRIP INTERLOCK WITH HOOD EXTINGUISHING SYSTEM.											
		A B C											

LIGHTING FIXTURE SCHEDULE				
MARK	MANUFACTURER AND CATALOG No.	SOURCE	MOUNTING	REMARKS
L22	H.E. WILLIAMS BP-22-LS-8-CS-DIM-UNV	LED 4200 LUMENS 3500K 40 WATTS	RECESSED	②
L22A	H.E. WILLIAMS BP-22-LS-8-CS-DIM-UNV	LED 3100 LUMENS 3500K 24 WATTS	RECESSED	②
L22B	H.E. WILLIAMS AP-22-L50-835-DIM-UNC	LED 5000 LUMENS 3500K	RECESSED	②
LS	H.E. WILLIAMS 75R-4-L50-835-DIM-UNV	LED 5000 LUMENS 3500K 33 WATTS	SURFACE	
LB2	H.E. WILLIAMS 75R-2-L15-835-DIM-UNV	LED 1500 LUMENS 11 WATTS	WALL	
L8W	ALCON LIGHTING 12100-10-R-8-L93-35K-RF-WH-4N1	LED 930 LUMENS/FT.	RECESSED	8' LENGTH
L14W	ALCON LIGHTING 12100-10-R-14-L93-35K-RF-WH-4N1	LED 930 LUMENS/FT.	RECESSED	14' LENGTH
LP10	FINELITE HP-2-P-0-10-B-835-F-96LG-120-SC-FC-10%	LED	PENDANT	①
RA	H.E. WILLIAMS 2DS-L9-835-DIM-UNV	LED 900 LUMENS 3500K 11 WATTS	RECESSED	
P1	LUMENS LINCOLN DRUM PENDANT	LED LAMP	PENDANT	AGED GOLD
P2	LUMENS FOSTER MINI PENDANT	LED LAMP	PENDANT	WHITE WITH GOLD
P3	HUDSON VALLEY HAVERHILL PENDANT 7308-OB	LED LAMP	PENDANT	CLEAR GLASS SHADE OLD BRONZE FINISH
S1	TROY LIGHTING ATWATER	LED LAMP	WALL	
S2	ALORA LIGHTING EDWIN 22 INCH LED WALL SCONCE	LED LAMP	WALL	
BB	ALLOW \$100.00 EACH	LED	WALL	
⊗	H.E. WILLIAMS EXIT-R-EM-WHT	LED	WALL OR CEILING	

① PROVIDE MATCHING ACOUSTICAL BAFFLES (SEE ARCHITECTURAL)
FINISH SHALL BE AS DIRECTED BY THE ARCHITECT

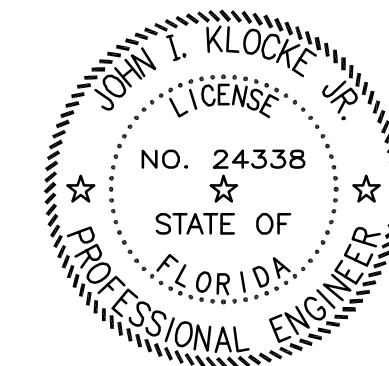
② FIXTURES INDICATED AS  SHALL BE PROVIDED WITH AN
8 WATT EMERGENCY UNIT BATTERY PACK.

smp.

SMP Architecture, P.A.
205 E INTENDENCIA STREET
PENSACOLA, FLORIDA 32502
P 850.432.7772
www.smp-arch.com • AAC001828

CERTIFICATION

CERTIFICATION :

SAVOY
PLACE321 N. DEVILLERS ST.
Pensacola, Florida
32501ALL DRAWINGS AND WRITTEN MATERIAL
HEREIN CONSTITUTE ORIGINAL AND UN-
PUBLISHED WORK OF THE ARCHITECT
AND MAY NOT BE DUPLICATED IN ANY
PART WITHOUT THE WRITTEN CONSENT
OF THE ARCHITECT.REVISIONS :
1 06/05/25 CITY COMMENTS
2 09/02/25 REVISION NO. 2

DRAWN BY : JPM

CHECKED BY : JIK

PROJECT NO. 2412

DATE : 05/07/25

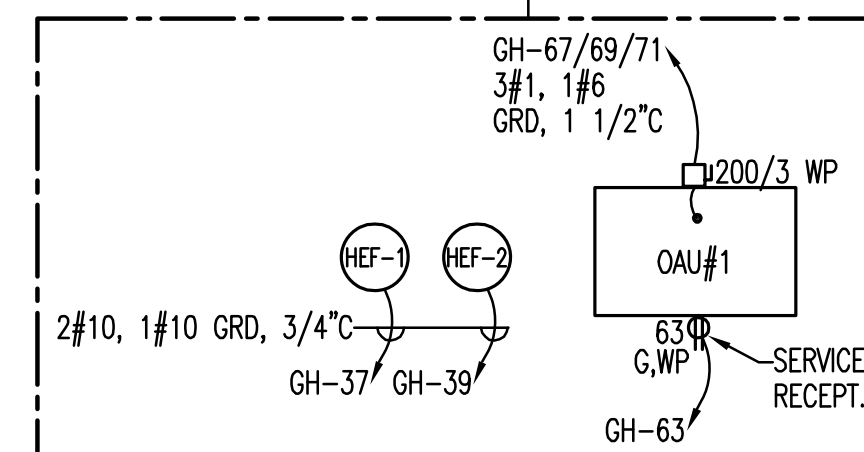
SHEET TITLE :
PARTIAL ENLARGED
POWER PLAN

SHEET NO. :

E103

©2024 SMP ARCHITECTURE

EQUIPMENT ELECTRICAL SCHEDULE									
ITEM NO.	QUANTITY	EQUIPMENT CATEGORY	VOLTS	PHASE	AMPS	PLUG	NEMA	DIRECT	ELECTRICAL AFF (IN)
1.1	1	OVEN, PICARD GAS	208	1	11.0			X	DFA
1.2	2	OVEN, MICROWAVE	208/240	1	20.0	X	6-20P		42
1.4	1	OVEN, ROTATING RACK, GAS	208/240	1	8.8			X	DFA
3.5	1	MIXER, FLOOR	120	1	9.5		5-15P		12
4.1	1	FREEZER, REACH-IN	115	1	9.6	X	5-15P		12
4E	1	EVAPORATOR COIL, WALK-IN COOLER	115	1	0.8	X		X	DFA
4L	1	LIGHTS, WALK-IN COOLER	115	1	0.8			X	DFA
4R	1	REMOTE CONDENSER, WALK-IN COOLER	208	1	11.4			X	DFA
4.3	1	REFRIGERATOR, AIR CURTAIN TYPE	115	1	9.4	X	5-15P		4.5
4.4	1	REFRIGERATOR, SANDWICH/SALAD PREP	115	1	10.3	X	5-15P		12
4.5	1	REFRIGERATED COUNTER TOP	115	1	2.0	X	5-15P		12
8.3	1	SLICER, FOOD	115	1	4.0	X	5-15P		42
8.9	1	WARMER, FOOD, ELECTRIC	120	1	5.8	X	5-20P		2
10	1	WAREWASHER, UNDERCOUNTER, LOW TEMP	115	1	13.2			X	7.5
13.15	1	ESPRESSO/CAPPUCINO MACHINE	220	1	22.0	X	L6-30P		42
13.20	1	ICE MAKER, UNDERCOUNTER	115	1	5.5	X	5-15P		12
13.23	1	GLASS DISPLAY MERCHANDISER, REFRIGERATED	115	1	5.4	X	5-15P		12
14	1	REFRIGERATOR, UNDERCOUNTER	115	1	2.0	X	5-15P		12
18	1	TEA BREWER	115	1	20.0	X	5-15P		42
25	1	DOUGH ROLLER	115	1	8.8	X	5-15P		12
26	1	SLICER, BREAD	115	1	6.2	X	5-15P		33
27	1	MIXER, FLOOR	200	3	12.0				56
HEF1	1	EXHAUST FAN, OVEN (ITEM 1.1)	115	1	20.0				SEE MECHANICAL
HEF2	1	EXHAUST FAN, OVEN (ITEM 1.4)	115	1	20.0				SEE MECHANICAL

SEE KITCHEN EQUIPMENT SHOP DRAWINGS FOR ADDITIONAL REQUIREMENTS.
VERIFY ALL ROUGH-IN REQUIREMENTS WITH KITCHEN EQUIPMENT SUPPLIER.EQUIPMENT LOCATED ON ROOF.
SEE MECHANICAL FOR LOCATION.

KEY NOTES

- 1 PROVIDE ISOLATED (INSULATED) GRD BAR. CONNECT TO PANEL GH GRD BAR WITH #6 AWG.
- 2 HUBBELL IG83620S ISOLATED GRD RECEPTACLES.
- 3 PROVIDE ROUGH-IN FOR POS SYSTEM NETWORK CABLE FOR FLOOR OUTLET WITH 1" STUBBED TO ABOVE CEILING.
- 4 PROVIDE POWER OUTLET AND PROVISIONS FOR POS SYSTEM KITCHEN PRINTER. PROVIDE RECEPTACLE CONNECTION TO GH-40. PROVIDE ROUGH-IN FOR NETWORK CABLE. STUB 3/4" TO ABOVE CEILING. COORDINATE LOCATION WITH KITCHEN EQUIPMENT SUPPLIER AND TENANT.
- 5 ASSUMES COMPACT COPPER THIN CONDUCTORS.

4' 0' 4' 8'
GRAPHIC SCALE 1/4"=1'-0"KLOCKE & ASSOCIATES, INC.
-Consulting Engineers-51 E. Gregory Street, Pensacola, Florida 32502, (850) 434-0989
C.A. #2695 JOHN I. KLOCKE, JR., P.E. #24338SEE MECHANICAL FOR LOCATIONS. COORDINATE
DISCONNECT AND SERVICE RECEPTACLE LOCATIONS
WITH MECHANICAL CONTRACTOR.COORDINATE LOCATION WITH ARCHITECT
AND KITCHEN EQUIPMENT SUPPLIER.30/2 WP
GH-1/363
G.W.P.
SERVICE RECEPTACLE
GH-63

GAAS WATER HEATERS

FF#1

GH-5

GH-10

GH-43/45

2#4, 1#10

GRD, 3/4"

C(5)

GH-9/11/13

GH-15

GH-17

GH-40

GH-31

GH-35

GH-33

GH-30

GH-28

GH-26

GH-24

GH-20/22

GH-16/18

GH-14

GH-12

GH-8/10

2#10, 1#10

GRD, 3/4"

C(5)

GH-6

GH-4

GH-2

GH-3

GH-1

GH-5

GH-10

GH-15

GH-1055

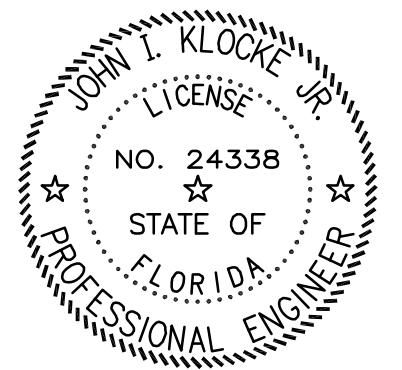
GH-1060

GH-1065

GH-1070

GH-1075

CERTIFICATION :



SAVOY PLACE

321 N. DEVILLERS ST.
Pensacola, Florida
32501ALL DRAWINGS AND WRITTEN MATERIAL
HEREIN CONSTITUTE ORIGINAL AND UN-
PUBLISHED WORK OF THE ARCHITECT
AND MAY NOT BE DUPLICATED IN ANY
PART WITHOUT THE WRITTEN CONSENT
OF THE ARCHITECT.

REVISIONS :

- 1 06/05/25 CITY COMMENTS
2 09/02/25 REVISION NO. 2

DRAWN BY : JPM

CHECKED BY : JJK

PROJECT NO. 2412

DATE : 05/07/25

SHEET TITLE :
PARTIAL ENLARGED
POWER PLAN

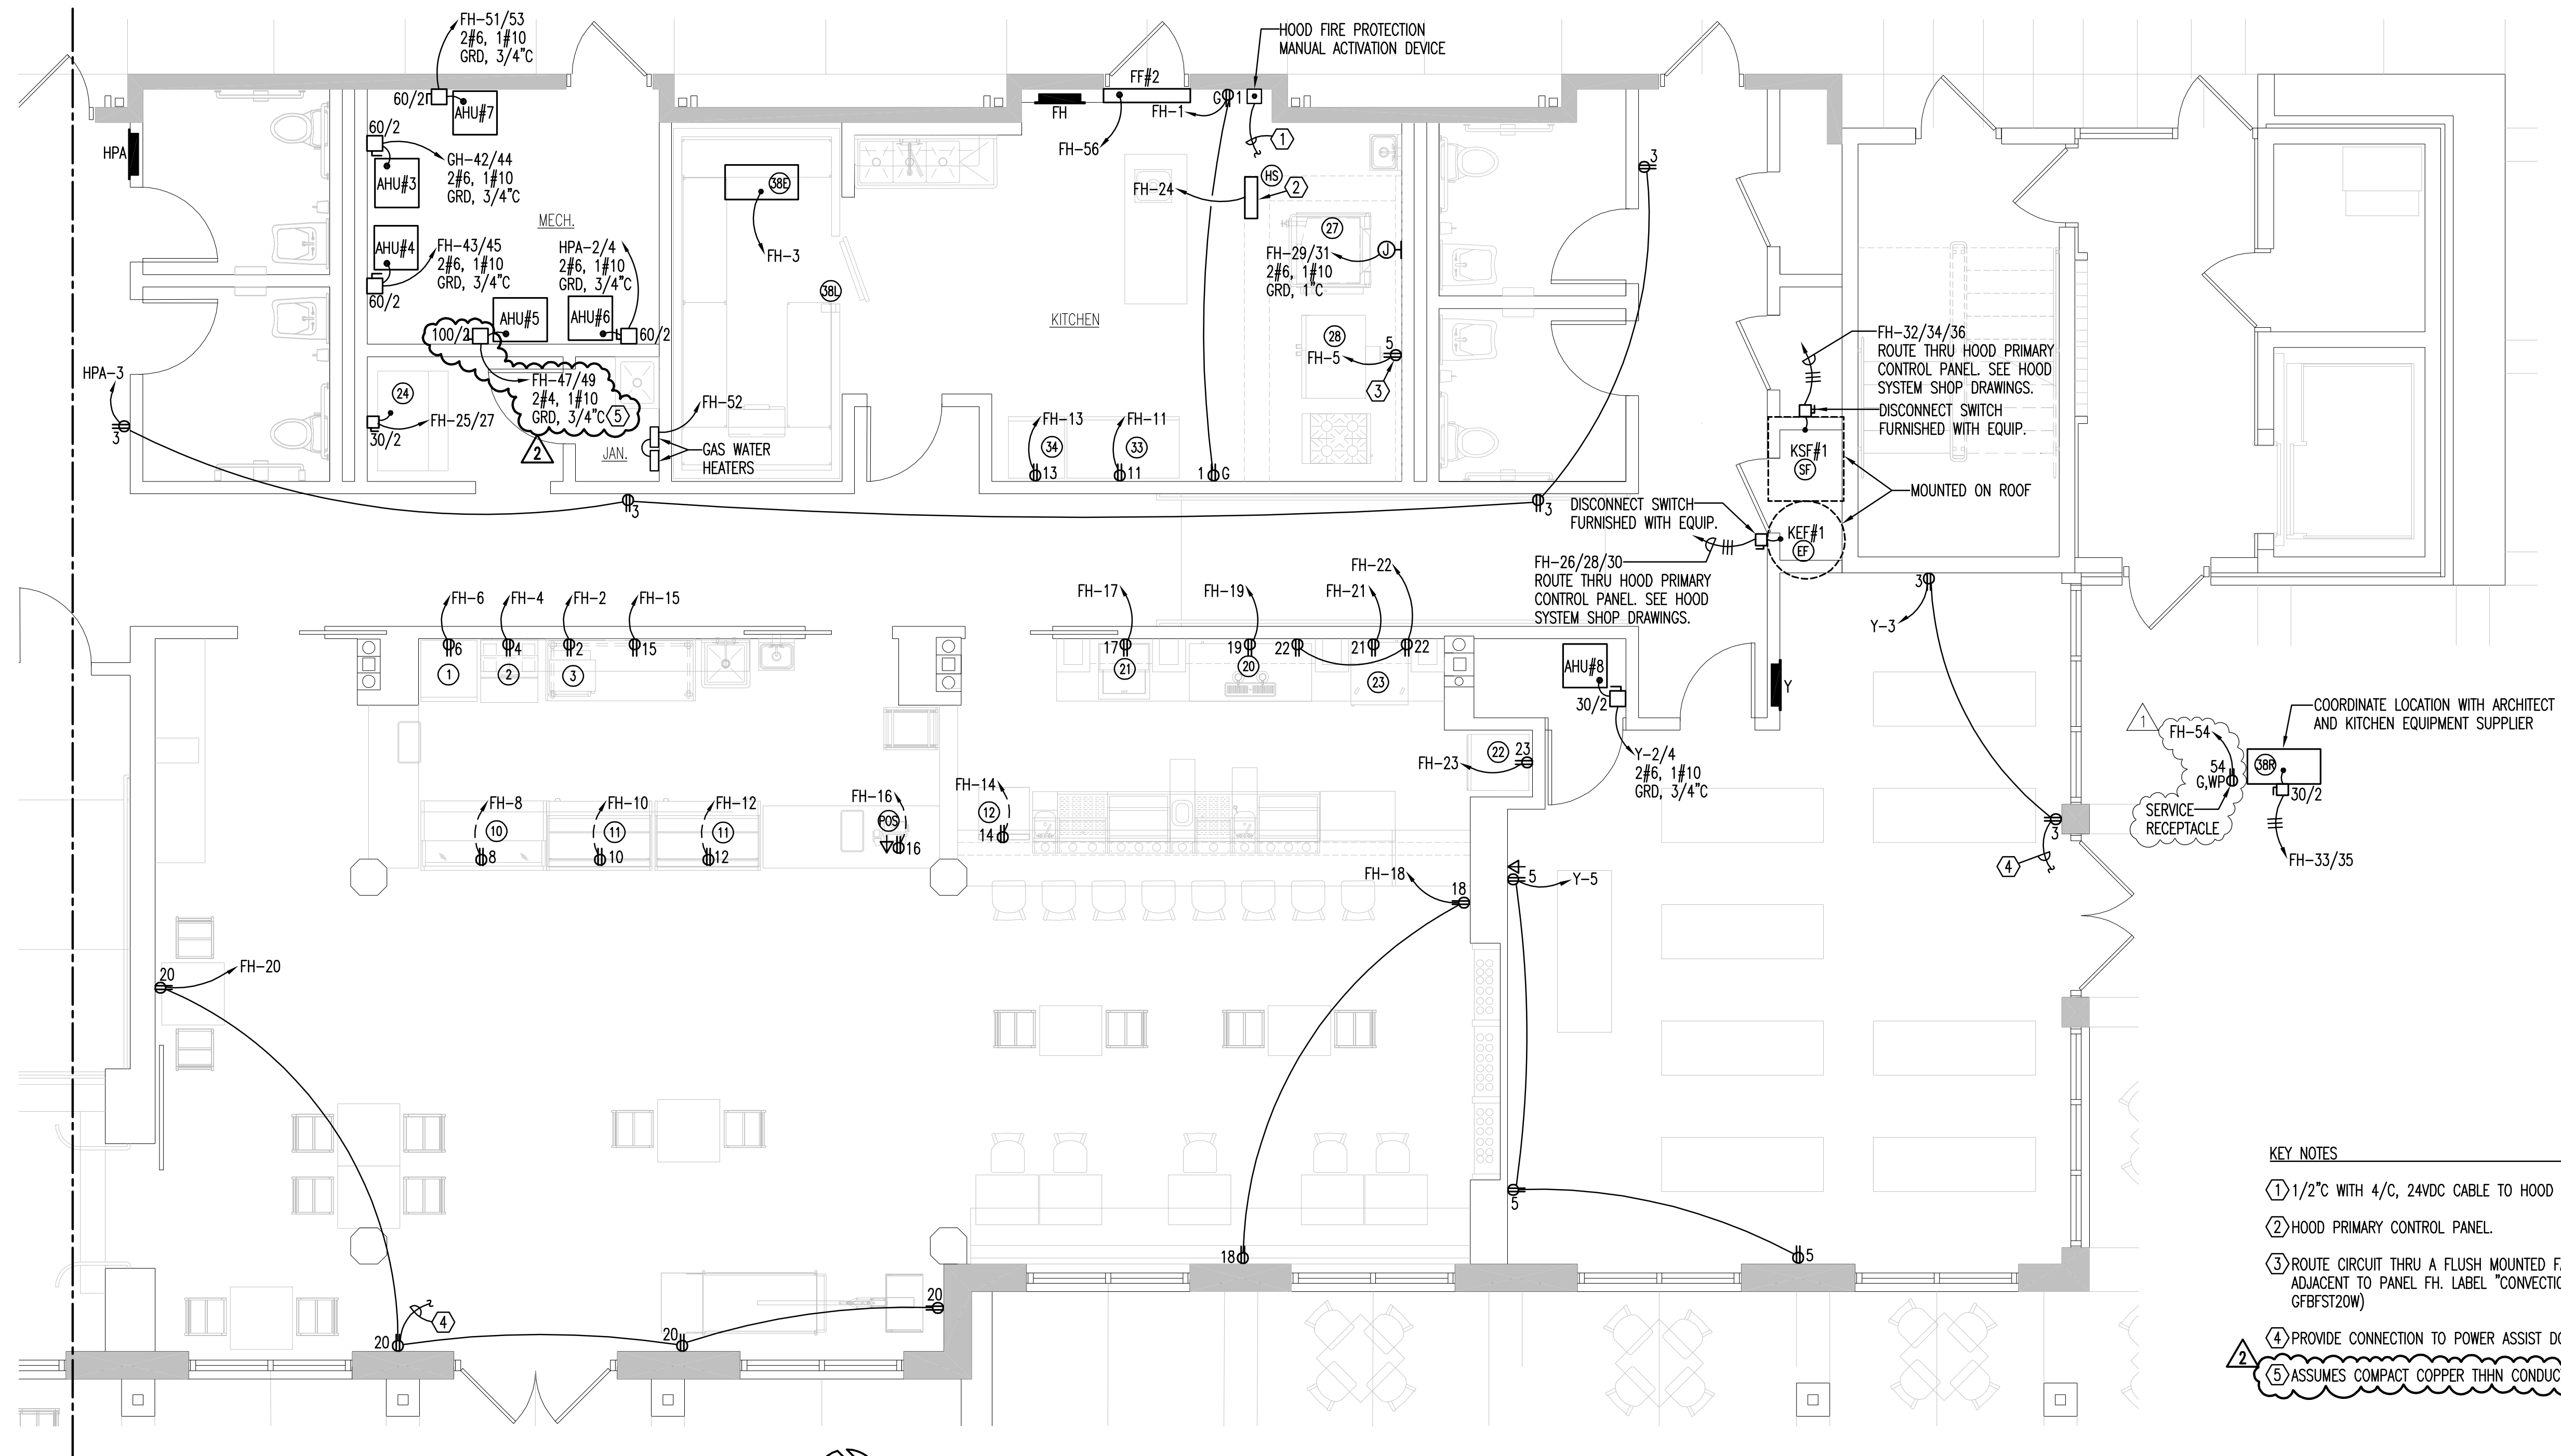
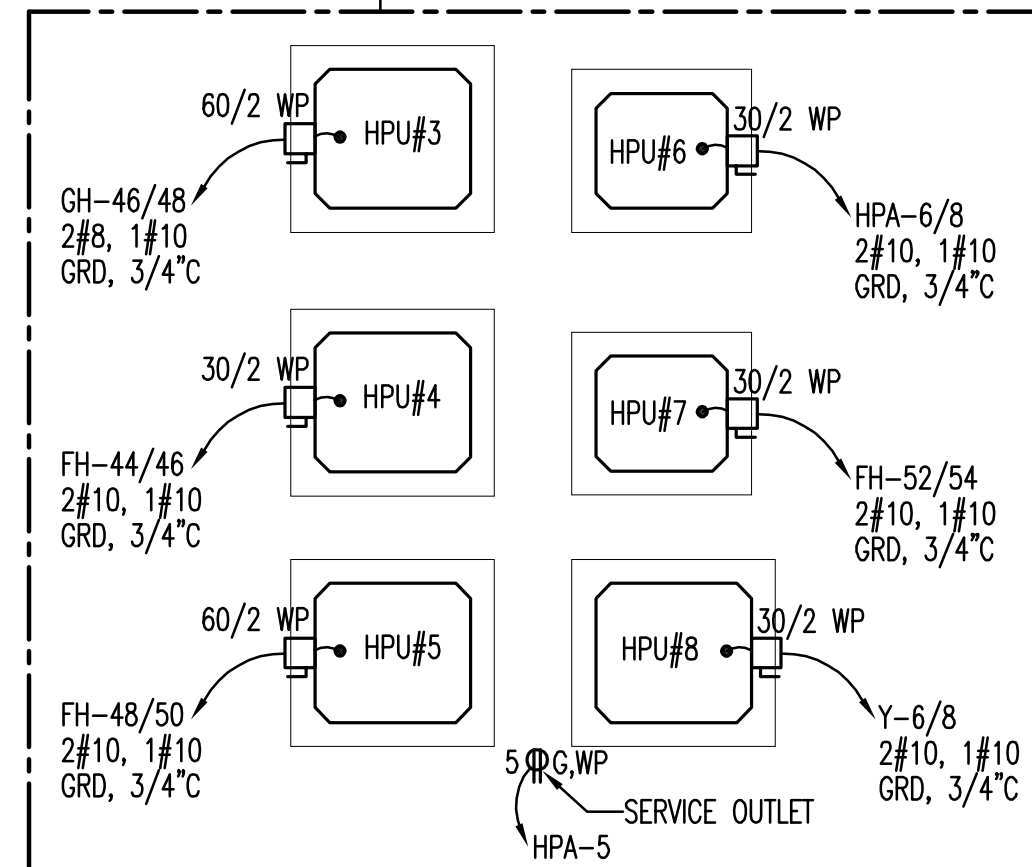
SHEET NO. :

E104

©2024 SMP ARCHITECTURE

EQUIPMENT ELECTRICAL SCHEDULE

ITEM NO.	QUANTITY	EQUIPMENT CATEGORY	VOLTS	PHASE	AMPS	NEMA	DIRECT	ELECTRICAL AFF (IN)	ELECTRICAL REMARKS
1	1	REFRIGERATOR, REACH-IN	115	1	3.0	5-15P		18	
2	1	REFRIGERATOR, SANDWICH/SALAD PREP	115	1	3.5	5-15P		18	
3	1	OVEN, CONVECTION, QUARTER-SIZE, ELECTRIC	208	1	13.0	6-15P		42	
10	1	DISPLAY CASE, REFRIGERATED	115	1	7.3	5-15P		6	STUB UP FROM BELOW (CONFIRM)
11	2	DISPLAY CASE, REFRIGERATED	115	1	11.0	5-15P		6	STUB UP FROM BELOW (CONFIRM)
12	1	WAREWASHER, UNDERCOUNTER, LOW TEMP	115	1	13.2		X	7.5	
20	1	DISPENSER, BEER	115	1	2.8	5-15P		18	
21	1	FROSTER/CHILLER, GLASS/MUG/PLATE	115	1	2.6	5-15P		18	
22	1	DISPLAY CASE, REFRIGERATED	115	1	5.2	5-15P		6	
23	1	REFRIGERATOR, UNDERCOUNTER, ADA	115	1	2.0	5-15P		18	
24	1	ICE MAKER WITH BIN	208	1	14.9		X	73.5	
27	1	TILT SKILLET	208	1	43.0		X	12	TILT SKILLET CAN BE SWAPPED OVER TO GAS UPON REQUEST
28	1	OVEN, CONVECTION, GAS	120	1	9.0			36	
33	1	FREEZER, REACH-IN	115	1	9.6	5-15P		18	
34	1	FREEZER, REACH-IN	115	1	4.1	5-15P		18	
38E	1	WALK-IN COOLER EVAPORATOR	115	1	10.0		X	DFA	FLEX TO CONNECTION POINT
38L	1	WALK-IN COOLER LIGHTS	115	1	10.0		X	DFA	FLEX TO CONNECTION POINT
38R	1	WALK-IN COOLER REMOTE CONDENSER	208	1	20.0		X	DFA	FLEX TO CONNECTION POINT. LOCATION TBD BY OWNER/ARCHITECT/ENGINEER
HS	1	HOOD SYSTEM LIGHTS & CONTROL PANEL	115	1	10.0		X	DFA	FLEX TO CONNECTION POINT
EF	1	HOOD SYSTEM EXHAUST FAN	208	3	20.0		X	DFA	FLEX TO CONNECTION POINT. SEE ECON AIR SUBMITTALS FOR DETAILED SPECIFICATIONS
SF	1	HOOD SYSTEM SUPPLY FAN	208	3	20.0		X	DFA	FLEX TO CONNECTION POINT. SEE ECON AIR SUBMITTALS FOR DETAILED SPECIFICATIONS
POS	1	POINT OF SALE	115	1	10.0	5-15P		42	CONFIRM SPECIFICATIONS WITH PROVIDER

SEE MECHANICAL FOR LOCATIONS. COORDINATE
DISCONNECT AND SERVICE RECEPTACLE LOCATIONS
WITH MECHANICAL CONTRACTOR.

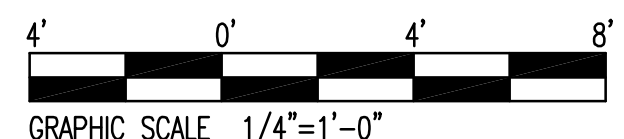
KEY NOTES

- 1 1/2" C WITH 4/C, 24VDC CABLE TO HOOD SYSTEM. SEE HOOD SHOP DRAWINGS.
2 HOOD PRIMARY CONTROL PANEL.
3 ROUTE CIRCUIT THRU A FLUSH MOUNTED FACELESS GFCI DEVICE MOUNTED
ADJACENT TO PANEL FH. LABEL "CONVECTION OVEN POWER RESET" (HUBBELL
GFBFST20W)
4 PROVIDE CONNECTION TO POWER ASSIST DOOR.
5 ASSUMES COMPACT COPPER THHN CONDUCTORS.



PARTIAL ENLARGED POWER PLAN

SCALE: 1/4" = 1'-0"



GRAPHIC SCALE 1/4" = 1'-0"

KLOCKE & ASSOCIATES, INC.

-Consulting Engineers-

51 E. Gregory Street, Pensacola, Florida 32502, (850) 434-0989
C.A. #2695 JOHN I. KLOCKE, JR., P.E. #24338